



3 BUILDING ELEVATION - SOUTH (CANOPY & SITE WALLS NOT SHOWN)  
SCALE: 3/32" = 1'-0"

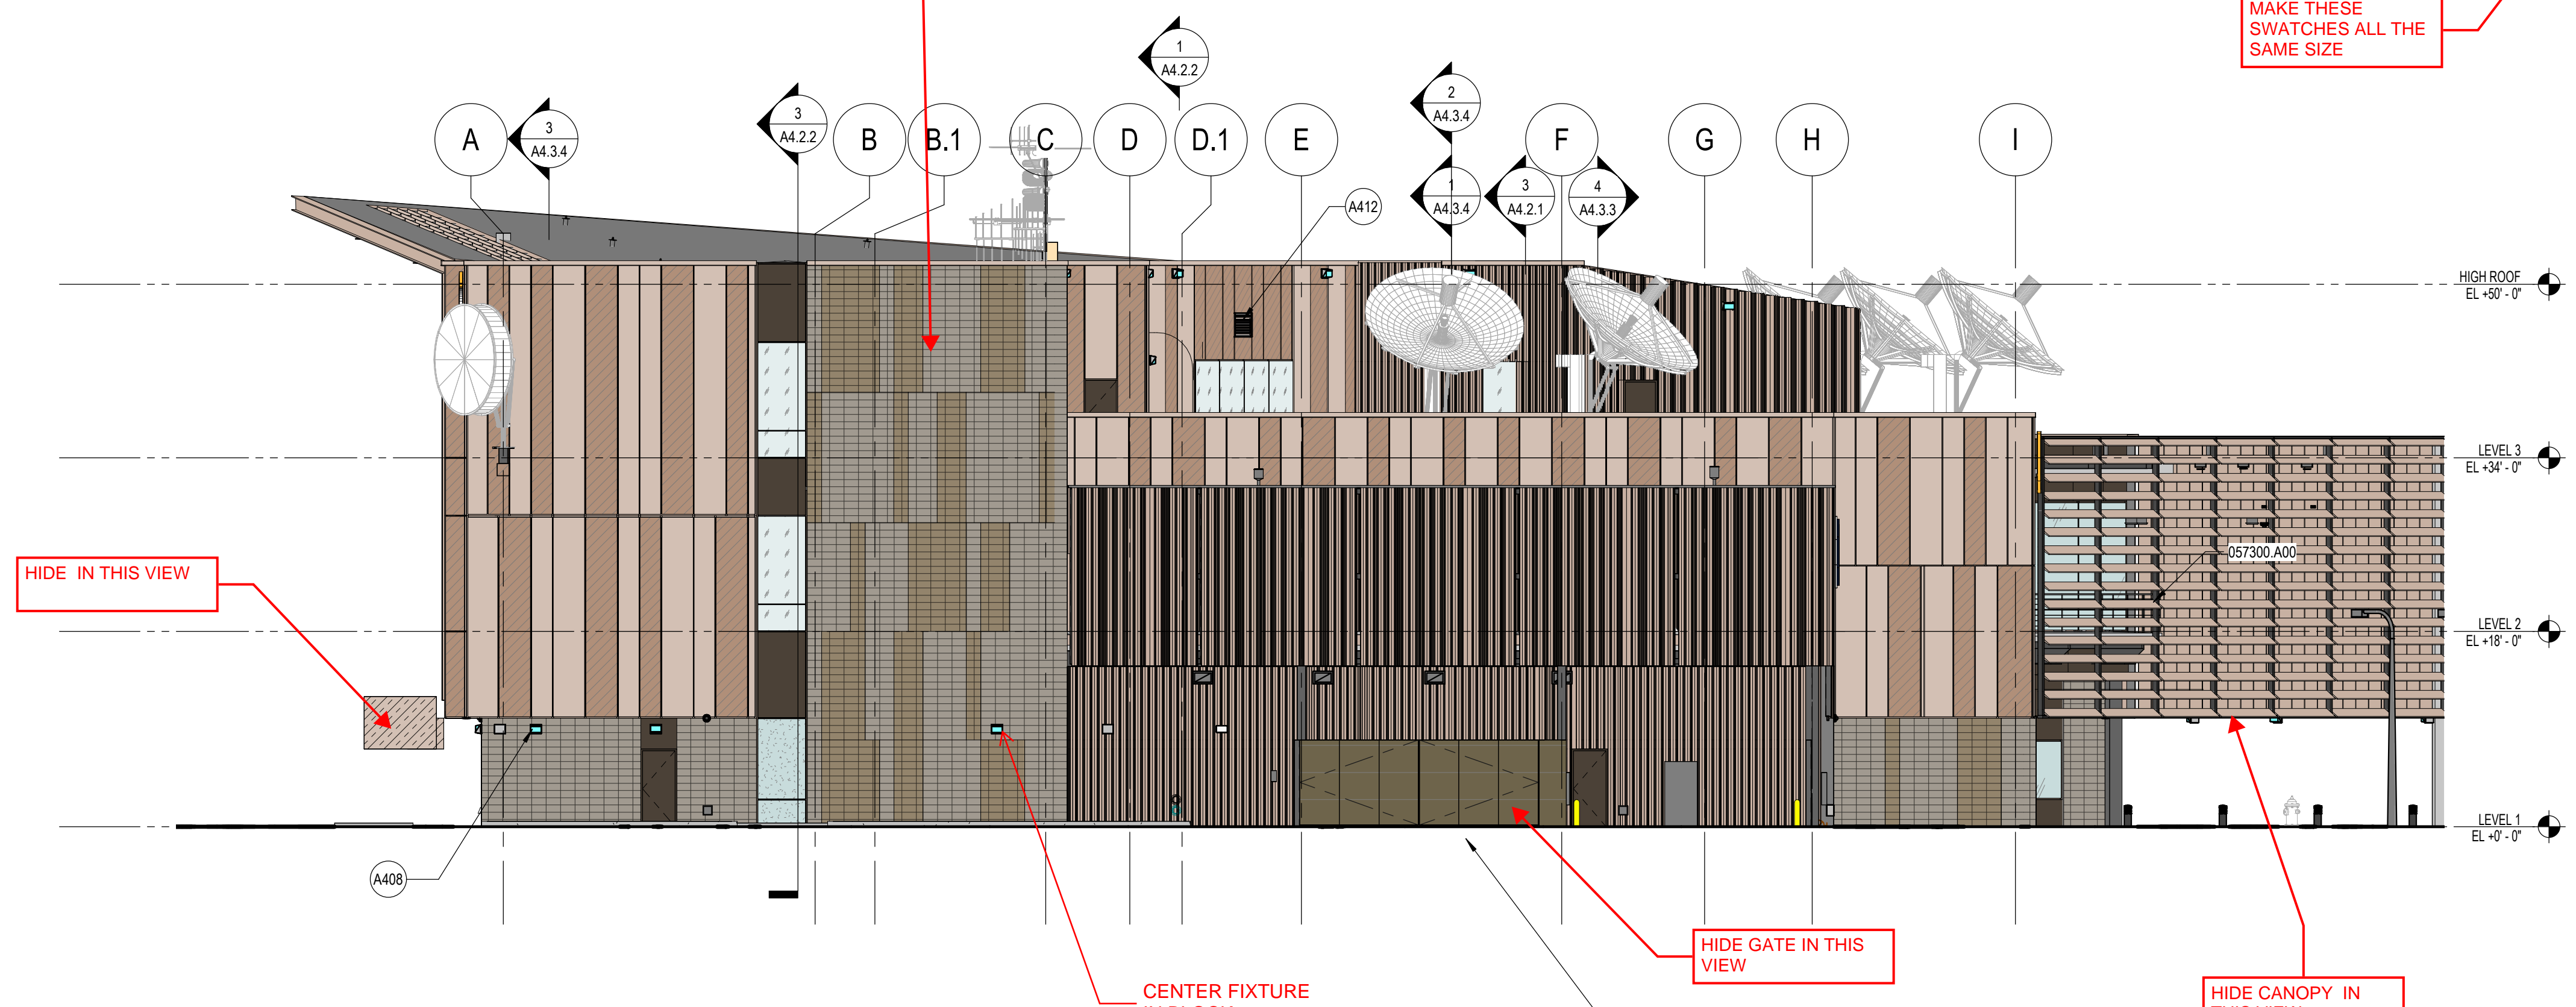

2 BUILDING ELEVATION - WEST (CANOPY & SITE WALLS NOT SHOWN)  
SCALE: 3/32" = 1'-0"

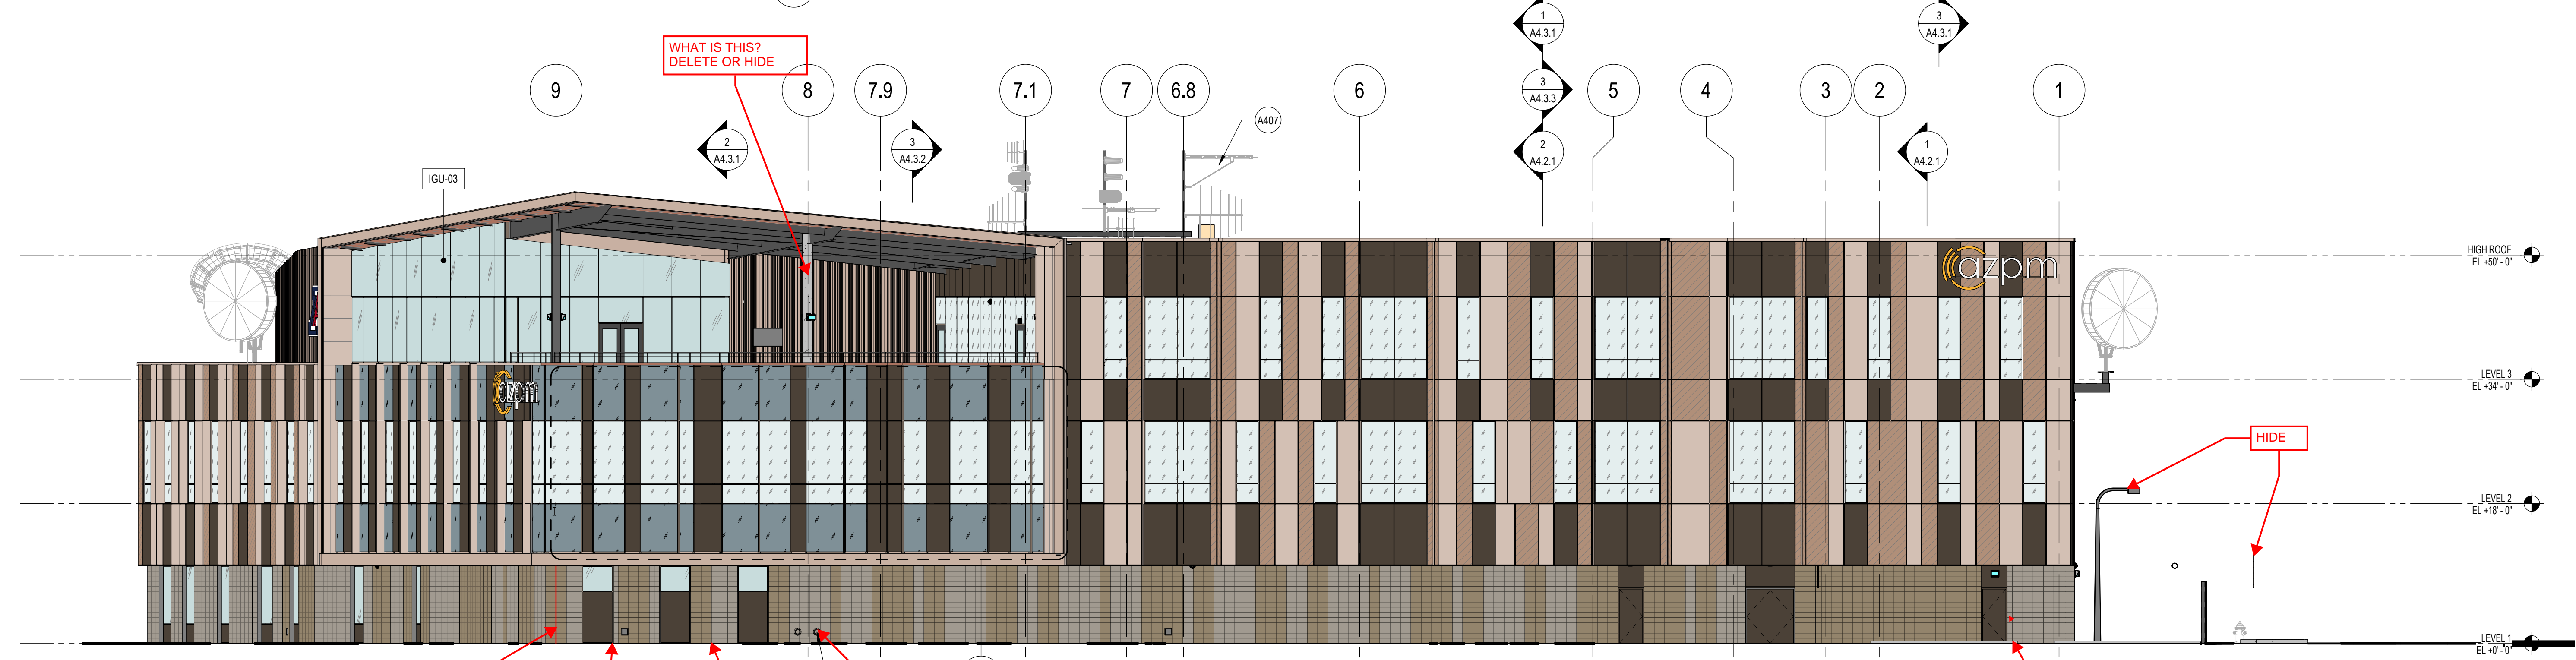

1 BUILDING ELEVATION - NORTH - SITE WALL NOT SHOWN  
SCALE: 3/32" = 1'-0"

### GRAPHIC LEGEND

	MP-01 TYPE: MCM WALL PANEL COLOR: CUSTOM (LIGHT) SIZE: 2" PANEL DEPTH
	MP-02 TYPE: MCM WALL PANEL COLOR: CUSTOM (DARK) SIZE: 1" PANEL DEPTH
	MP-03 TYPE: FORMED METAL WALL PANEL MANUFACTURER: CENTRIA SERIES: CONCEPT SERIES COLOR: MATCH MP-01 INSTALLATION: CONCEALED FASTENER
	MP-04 TYPE: MCM WALL PANEL COLOR: DARK BRONZE SIZE: 1" PANEL DEPTH
	IGU-01 TYPE: INSULATED GLAZING UNIT MANUFACTURER: VIRACON SERIES: VUE1-50 FINISH: VISION
	IGU-02 TYPE: INSULATED GLAZING UNIT MANUFACTURER: VIRACON SERIES: VUE1-50 COLOR: XYZ FINISH: SPANDREL
	IGU-03 TYPE: INSULATED GLAZING UNIT MANUFACTURER: VIRACON SERIES: VNE13-63 FINISH: VISION
	CMU-01 TYPE: MASONRY VENEER MANUFACTURER: TRENDSTONE COLOR: MISSION WHITE FINISH: HONED FACE SIZE: 8X4X16 INSTALLATION: STACK BOND
	CMU-02 TYPE: MASONRY VENEER MANUFACTURER: TRENDSTONE COLOR: PEARL FINISH: HONED FACE SIZE: 8X4X16 INSTALLATION: STACK BOND
	P-10 EXTTYPE: PAINT COLOR: MATCH MP-01
	P-11 EXTTYPE: PAINT MANUFACTURER: xyz COLOR: xyz
	P-12 EXTTYPE: PAINT MANUFACTURER: XYZ COLOR: MATCH MP-04

### GENERAL SHEET NOTES

- REFER TO THE A0.X SERIES SHEETS FOR ARCHITECTURAL GENERAL NOTES, DRAWING REFERENCE AND MATERIAL SYMBOLS, ABBREVIATIONS, AS WELL AS DIMENSIONING CONVENTIONS USED ON THIS SHEET.
- REFER TO AND COORDINATE WITH STRUCTURAL, MECHANICAL, PLUMBING, AND ELECTRICAL FOR ADDITIONAL INFORMATION NOT SHOWN ON THIS SHEET.
- REFER TO AND COORDINATE WITH CIVIL DRAWINGS FOR ALL FINISH GRADES.
- REFER TO THE A4.4.X SERIES SHEETS FOR ENLARGED EXTERIOR ELEVATIONS.
- REFER TO THE A5.4.X SERIES SHEETS FOR EXTERIOR WINDOW AND LOUVER FRAME ELEVATIONS.

### REFERENCE KEYNOTES

051200.A00	STRUCTURAL STEEL FRAMING
051200.A13	STRUCTURAL STEEL COLUMN
055000.A08	DECORATIVE METAL RAILINGS
057300.A00	DECORATIVE METAL RAILINGS
074213.13.A00	FORMED METAL WALL PANEL
074213.23.A02	ALUMINUM-FACED COMPOSITE WALL PANEL
083323.A01	OVERHEAD COLLING DOOR
084213.A02	ALUMINUM ENTRANCE DOOR

### SHEET KEYNOTES

A405	ROOF DRAIN AND OVERFLOW OUTLET, CENTER IN BLOCK
A407	BROADCAST EQUIPMENT
A408	LIGHT FIXTURE - REFER TO ELECTRICAL SCHEDULE
A411	HOLLOW METAL DOOR AND FRAME - REFER TO DOOR SCHEDULE
A412	MECHANICAL EXHAUST LOUVER - CENTERED BETWEEN VERTICAL PANEL JOINTS, FINISH TO MATCH ADJACENT WALL FINISH

**THE UNIVERSITY OF ARIZONA**  
ARIZONA PUBLIC MEDIA FACILITY  
2685 S. CATALYST DR.  
TUCSON, AZ 85713

**DPR CONSTRUCTION**  
DPR CONSTRUCTION  
222 N 44TH ST, PHOENIX, AZ 85034  
602.808.0500  
dpr.com

**swaim ASSOCIATES LTD ARCHITECTS AIA**  
SWAIM ASSOCIATES  
7350 E SPEEDWAY BLVD, SUITE 210  
TUCSON, AZ 85710  
520.326.3700  
swaimaia.com

**RBDG**  
Russ Berger Design Group

RUSS BERGER DESIGN GROUP  
3300 DALLAS PKWY, SUITE 200  
PLANO, TX 75093  
972.661.5222  
rbdg.com

ISSUED FOR	REV	DATE
50% Construction Documents		02 FEB 2023
Design Development		23 NOV 2022
Schematic Design		22 AUG 2022

NOT FOR CONSTRUCTION

### SHEET TITLE

**EXTERIOR BUILDING ELEVATIONS**

PROJECT NUMBER: 13723 / 22-9576

**CD** **A4.1.1**

SHEET NUMBER